


RECESSED LUMINAIRE WITH LOUVRE AND WHITE POWDER COATED BACKING - REFLECTOR, WHITE POWDER COAT PAINT FINISH. W/ 2-18 WATTS LED TUBE LIGHT

**1 REFLECTED CEILING PLAN**  
A6 A6 SCALE : 1:120 M

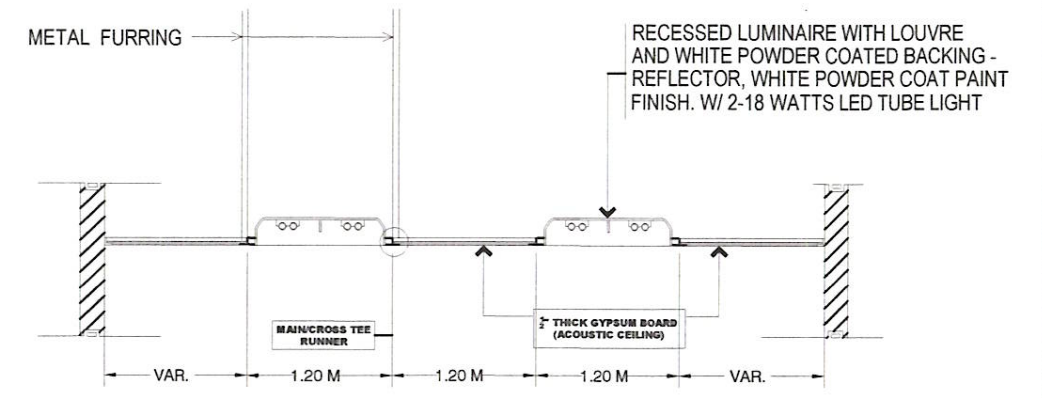

**2 SECTION OF LIGHTING DETAIL**  
A6 A6 SCALE 1:50 METERS

SATISFACTORY TO:  
*[Signature]*  
**BEATRIX S. ANAGARAN**  
MNGR, BUSINESS AND INVESTMENT GRP.




CADD BY:  
*[Signature]*  
ASL  
DESIGNED BY:  
*[Signature]*  
ASL

CHECKED BY:  
*[Signature]*  
**EDISON D. ICO**  
DIV. CHIEF III PDD

REVIEWED BY:  
*[Signature]*  
**GARY P. FERNANDEZ**  
MANAGER, ENG'G DEPARTMENT

RECOMMENDED:  
*[Signature]*  
**MARCO A. ESTABILLO**  
DA FOR PWTSG

APPROVED:  
*[Signature]*  
**ATTY. WILMA T. EISMA**  
CHAIRMAN & ADMINISTRATOR

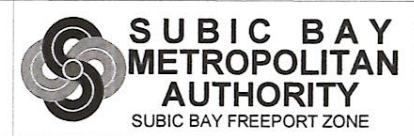

PROJECT TITLE:  
**RENOVATION OF GBID OFFICE AT BLDG. 662**  
LOC. BLDG 662 TAFT ST. SBFZ

SHEET NO.  
**A-6**  
7 of 17